



- ELECTRICAL LEGEND**
- ⊠ CATV JACK (2 RG-6 COAX CABLES)
  - ⊠ TELEPHONE (DATA JACK, 2 CAT 6 CABLES AND JACKS)
  - ⊠ RECPTACLE - DUPLEX
  - ⊠ RECPTACLE - DOUBLE DUPLEX
  - ⊠ RECPTACLE - DUPLEX FLOOR MOUNTED
  - ⊠ RECPTACLE - DUPLEX GROUND FAULT INTERRUPTER / ABOVE COUNTER

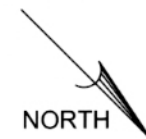

1  
A311  
**UNIT 311**

1/8"=1'-0"

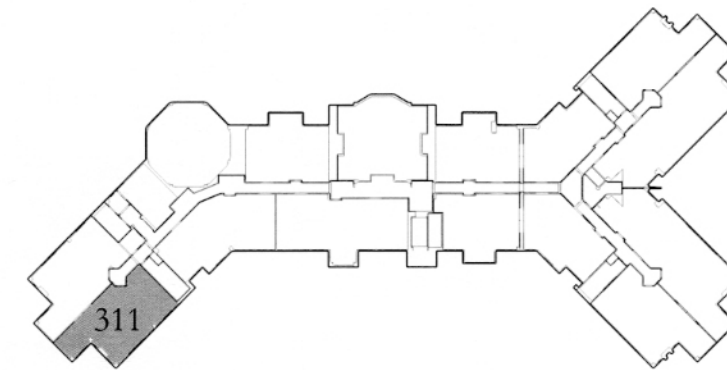

**3RD FLOOR KEY PLAN**



NTS

**HART HOWERTON**  
PLANNERS-ARCHITECTS  
LANDSCAPE ARCHITECTS  
INTERIOR DESIGNERS  
HART/HOWERTON, PLANNING, ARCHITECTURE AND  
LANDSCAPE ARCHITECTURE, PC  
10 East 40th Street, New York, NY 10016

13 North 23rd Street  
P.O. Box 1439  
Billings, Montana 59101



**SPANISH PEAKS LODGE**  
*Big Sky, Montana*

© 2005 HART HOWERTON, LTD. PLANNERS, ARCHITECTS, LANDSCAPE ARCHITECTS. The designs and concepts shown are the sole property of Hart Howerton. The drawings may not be used except with the expressed written consent of Hart Howerton.

DRAWING TITLE:  
**UNIT 311**

PROJECT #: HH: 03-545 CTA: SPL  
DRAWN BY: RGS  
CHECKED BY: RSE  
DATE:

12-15-06

DRAWING NO:  
**A311**